


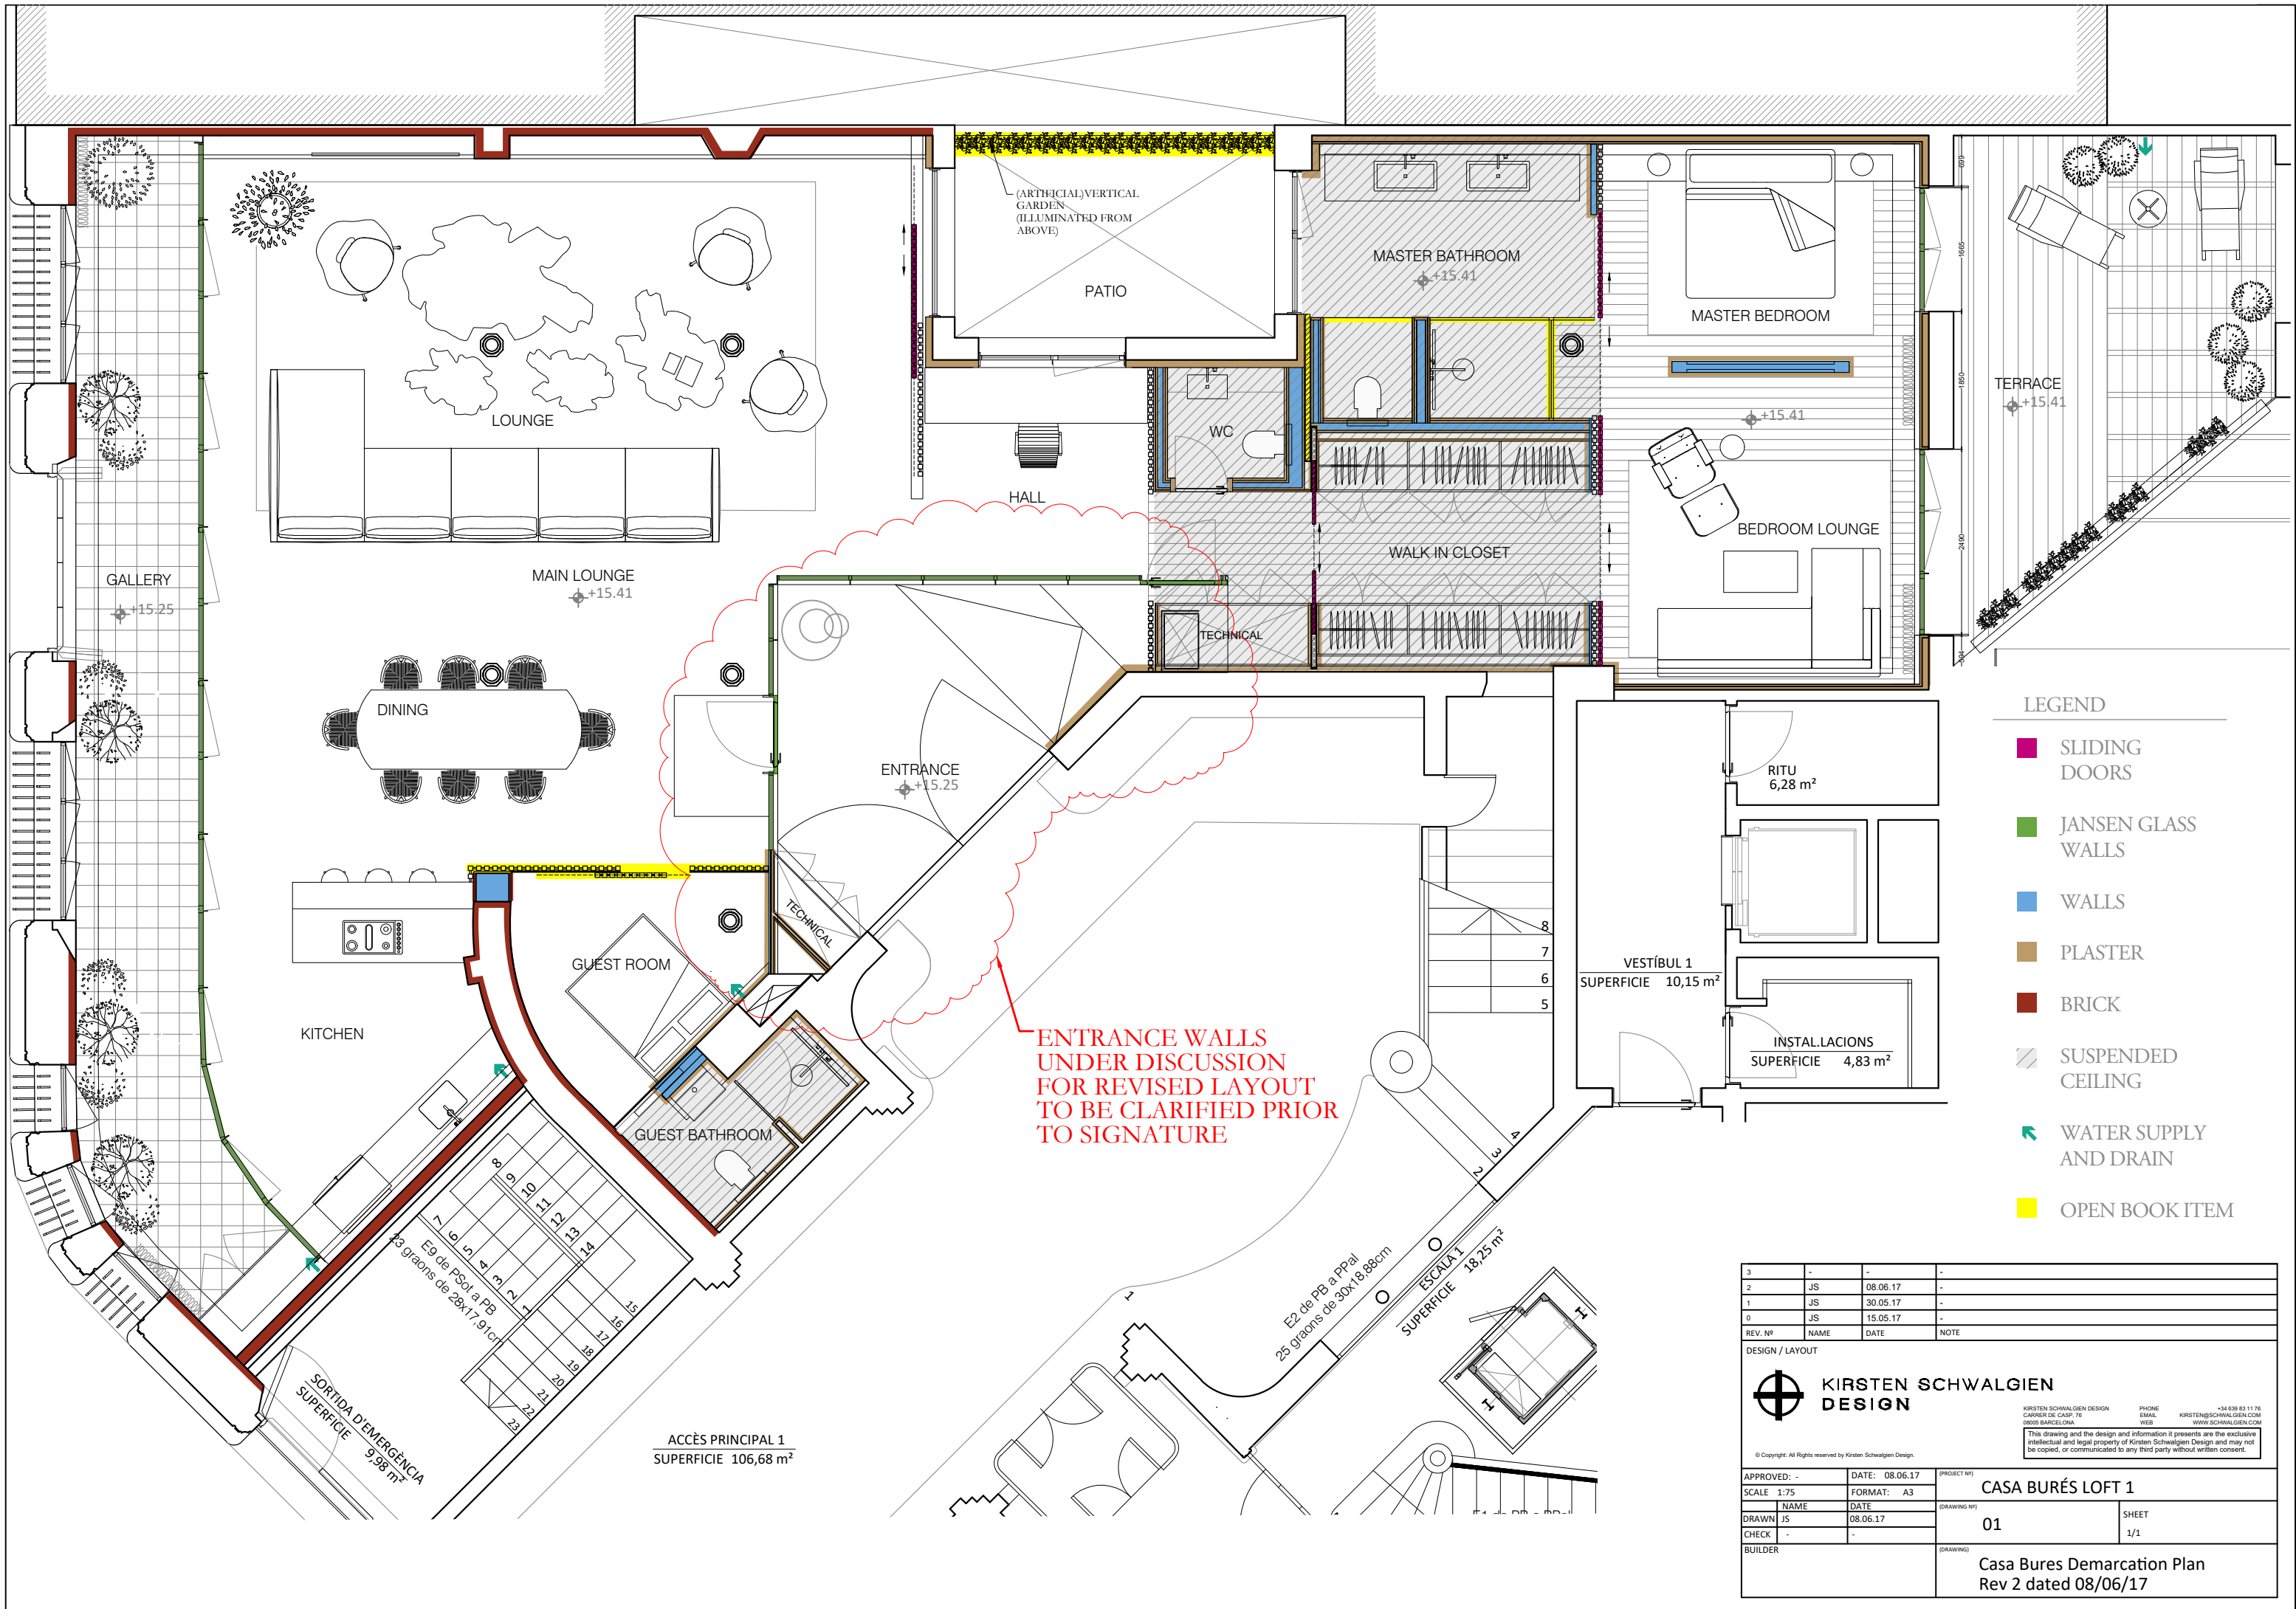

3	-	-	-
2	JS	08.06.17	-
1	JS	30.05.17	-
0	JS	15.05.17	-
REV. Nº	NAME	DATE	NOTE

DESIGN / LAYOUT



KIRSTEN SCHWALGIEN
DESIGN

KIRSTEN SCHWALGIEN DESIGN
CARRER DE CASP, 76
08005 BARCELONA

PHONE
+34 639 83 11 76


EMAIL
KIRSTEN@SCHWALGIEN.COM

WEB
WWW.SCHWALGIEN.COM

This drawing and the design and information it presents are the exclusive intellectual and legal property of Kirsten Schwalgien Design and may not be copied, or communicated to any third party without written consent.

© Copyright: All Rights reserved by Kirsten Schwalgien Design.

APPROVED: -	DATE: 08.06.17	(PROJECT Nº)	
SCALE 1:75	FORMAT: A3	CASA BURÉS LOFT 1	
DRAWN NAME JS	DATE 08.06.17	(DRAWING Nº)	
CHECK -	-	01	SHEET 1/1
BUILDER		(DRAWING)	
		Casa Bures Demarcation Plan Rev 2 dated 08/06/17	

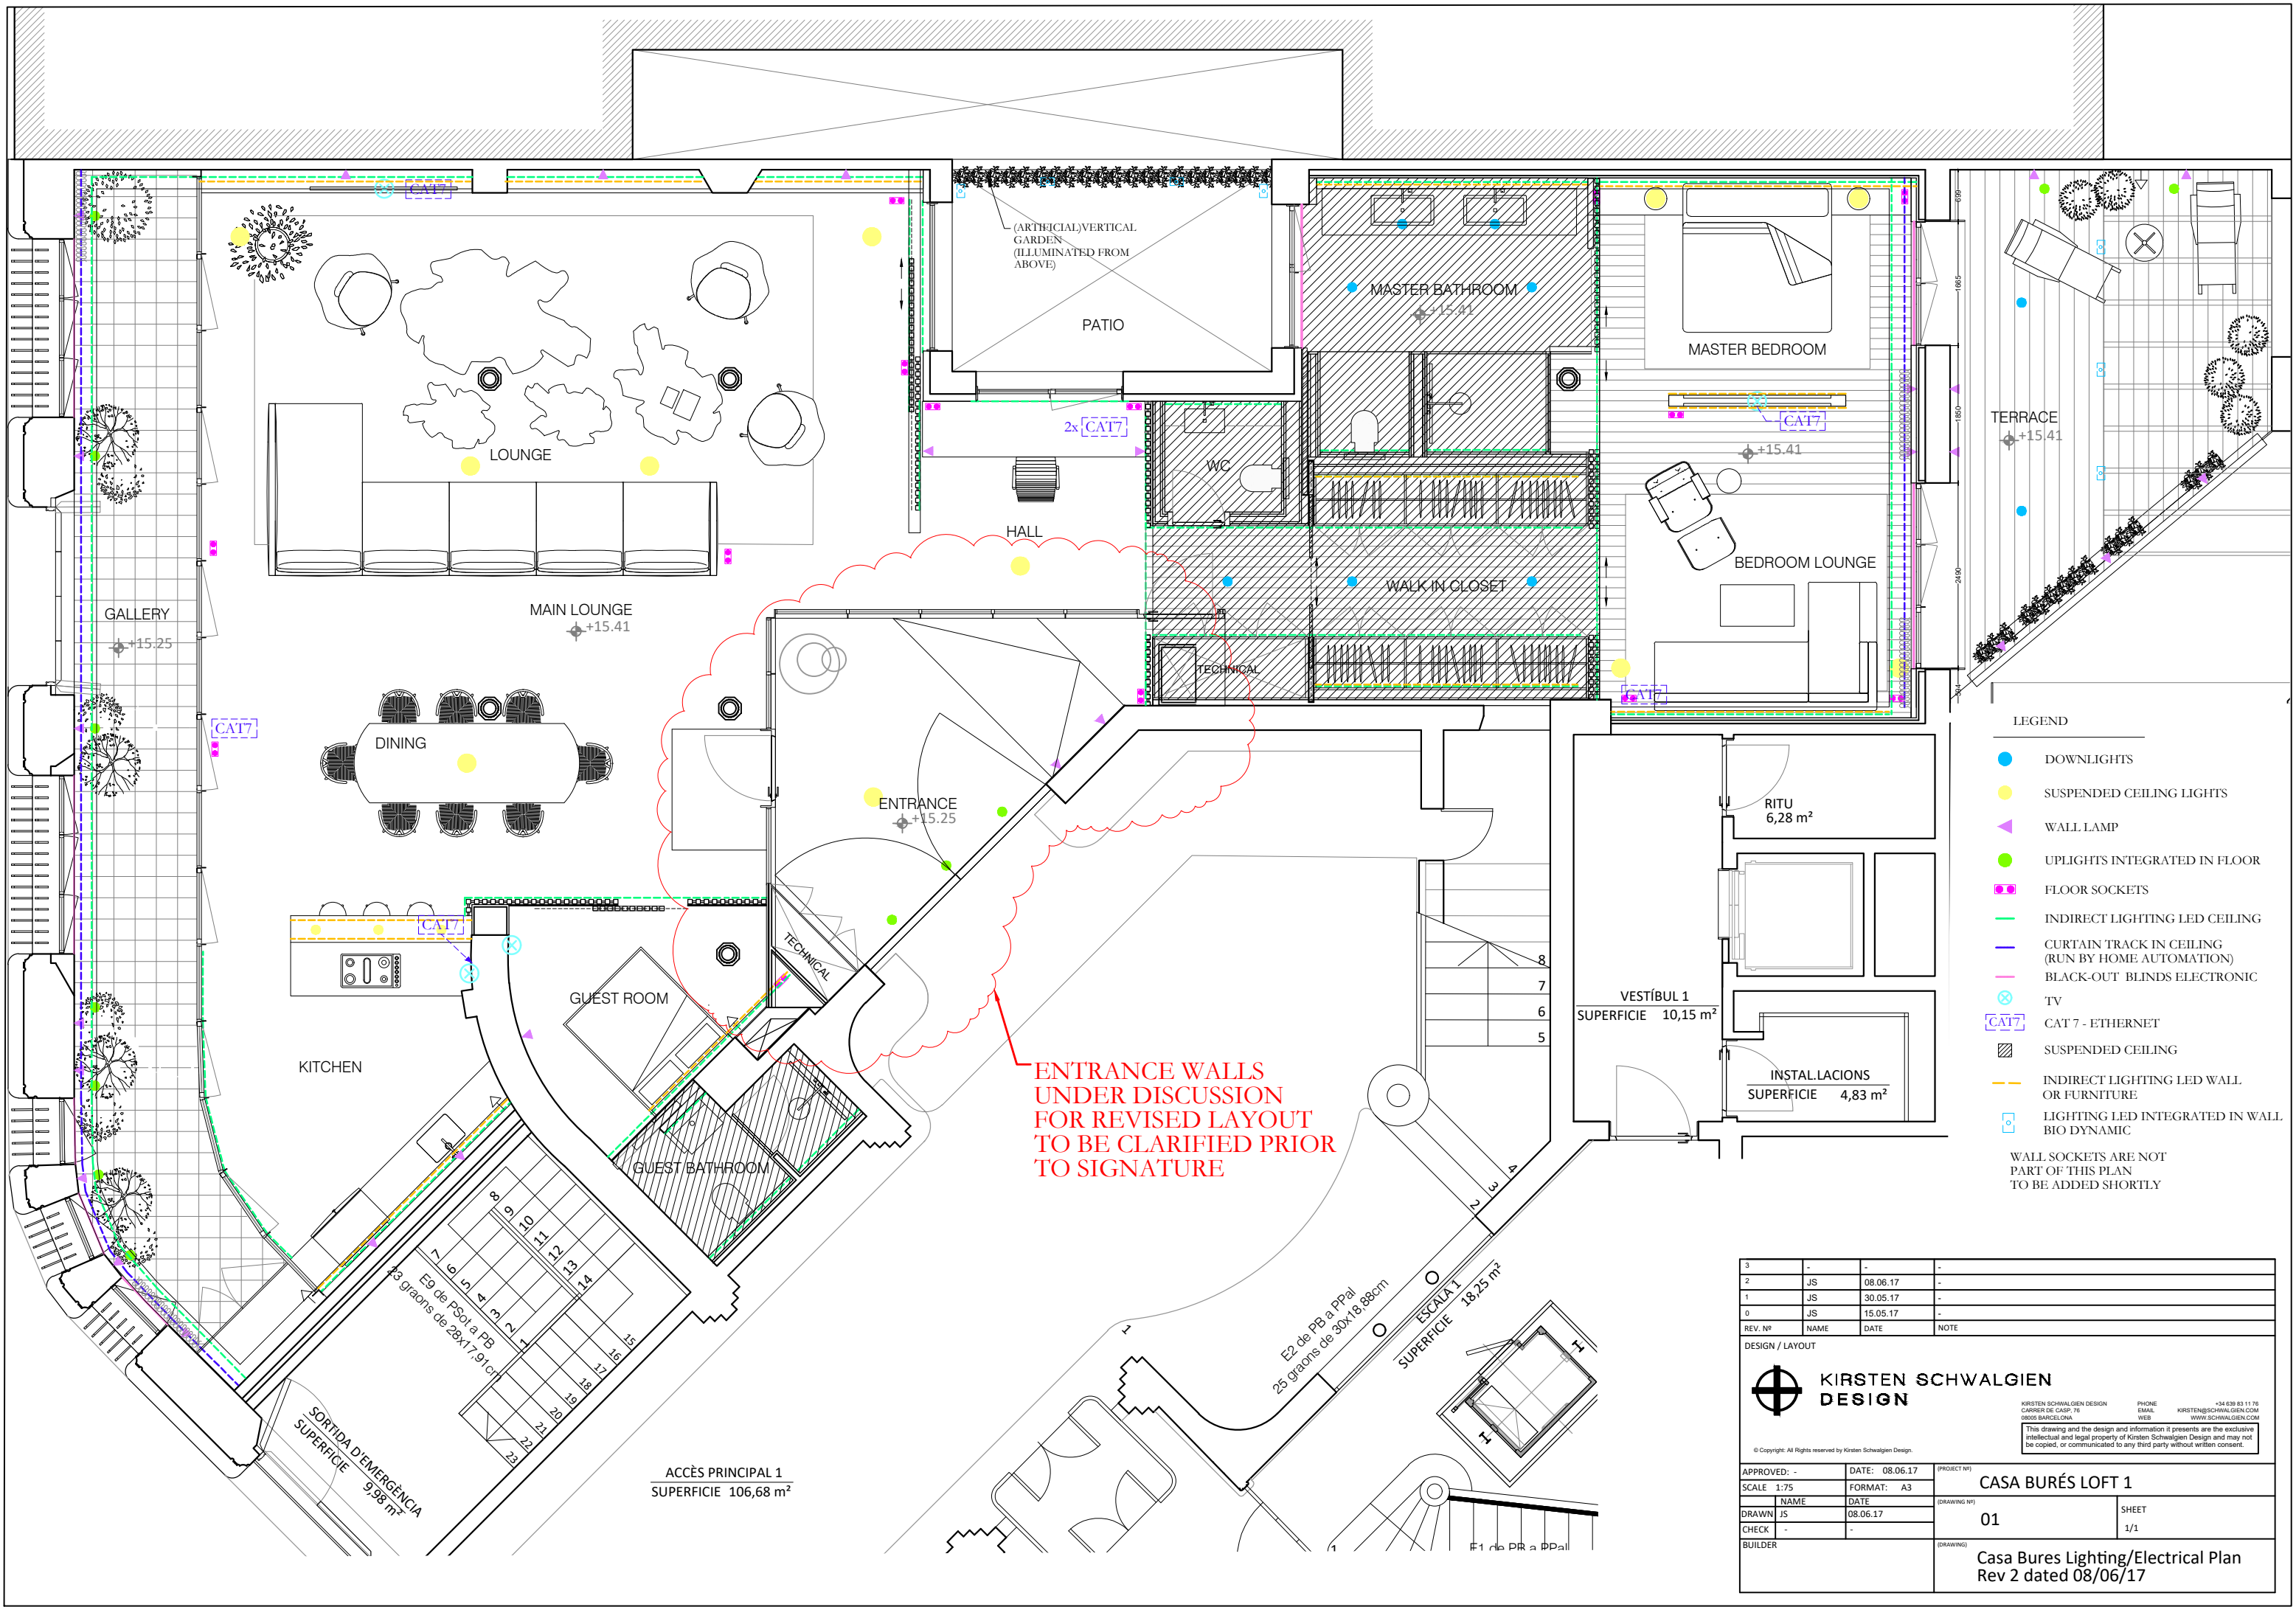

- LEGEND
- DOWNLIGHTS
 - SUSPENDED CEILING LIGHTS
 - ▲ WALL LAMP
 - UPLIGHTS INTEGRATED IN FLOOR
 - FLOOR SOCKETS
 - INDIRECT LIGHTING LED CEILING
 - CURTAIN TRACK IN CEILING (RUN BY HOME AUTOMATION)
 - BLACK-OUT BLINDS ELECTRONIC
 - ⊗ TV
 - ⌈ CAT 7 - ETHERNET
 - ▨ SUSPENDED CEILING
 - INDIRECT LIGHTING LED WALL OR FURNITURE
 - LIGHTING LED INTEGRATED IN WALL BIO DYNAMIC
- WALL SOCKETS ARE NOT PART OF THIS PLAN TO BE ADDED SHORTLY

3	-	-	-
2	JS	08.06.17	-
1	JS	30.05.17	-
0	JS	15.05.17	-
REV. Nº	NAME	DATE	NOTE

DESIGN / LAYOUT

KIRSTEN SCHWALGIEN
DESIGN


KIRSTEN SCHWALGIEN DESIGN
CARRER DE CASP, 76
08005 BARCELONA

PHONE +34 639 83 11 76
EMAIL KIRSTEN@SCHWALGIEN.COM
WEB WWW.SCHWALGIEN.COM


This drawing and the design and information it presents are the exclusive intellectual and legal property of Kirsten Schwalgien Design and may not be copied, or communicated to any third party without written consent.

© Copyright: All Rights reserved by Kirsten Schwalgien Design.


APPROVED: -	DATE: 08.06.17	(PROJECT Nº)
SCALE 1:75	FORMAT: A3	CASA BURÉS LOFT 1
DRAWN JS	DATE 08.06.17	(DRAWING Nº)
CHECK -	-	01
BUILDER		SHEET 1/1
	(DRAWING)	Casa Bures Lighting/Electrical Plan Rev 2 dated 08/06/17

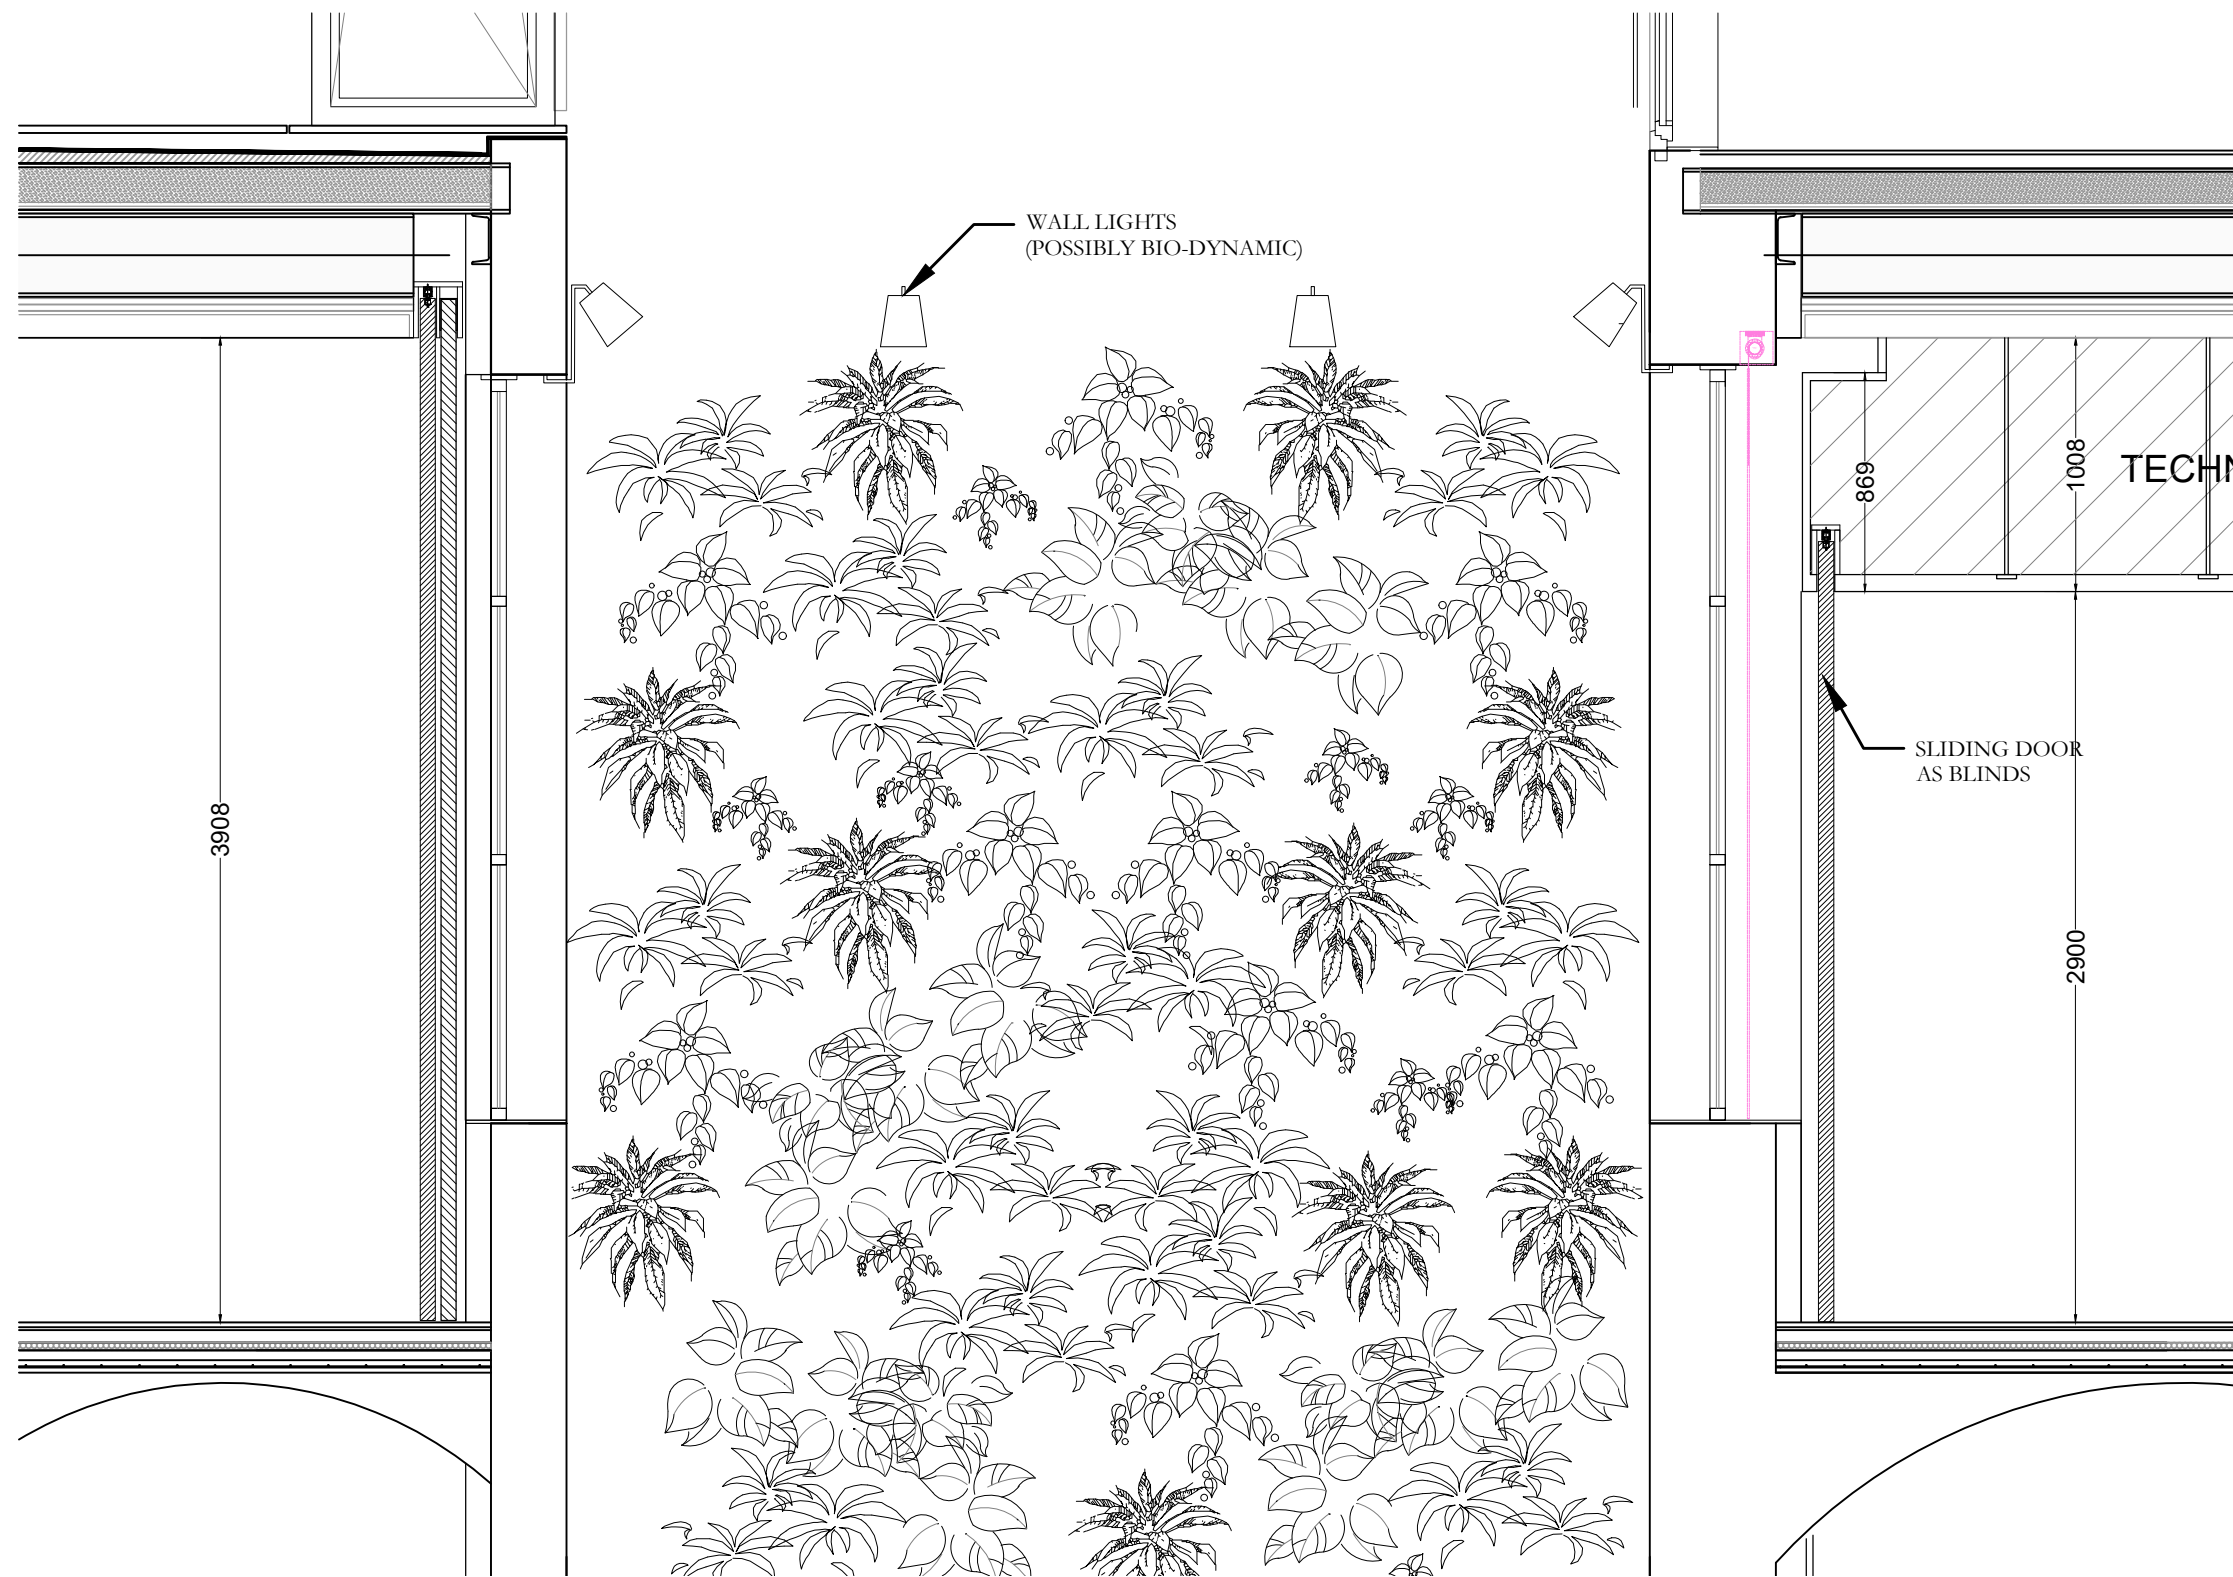

SECTION A VERTICAL GARDEN

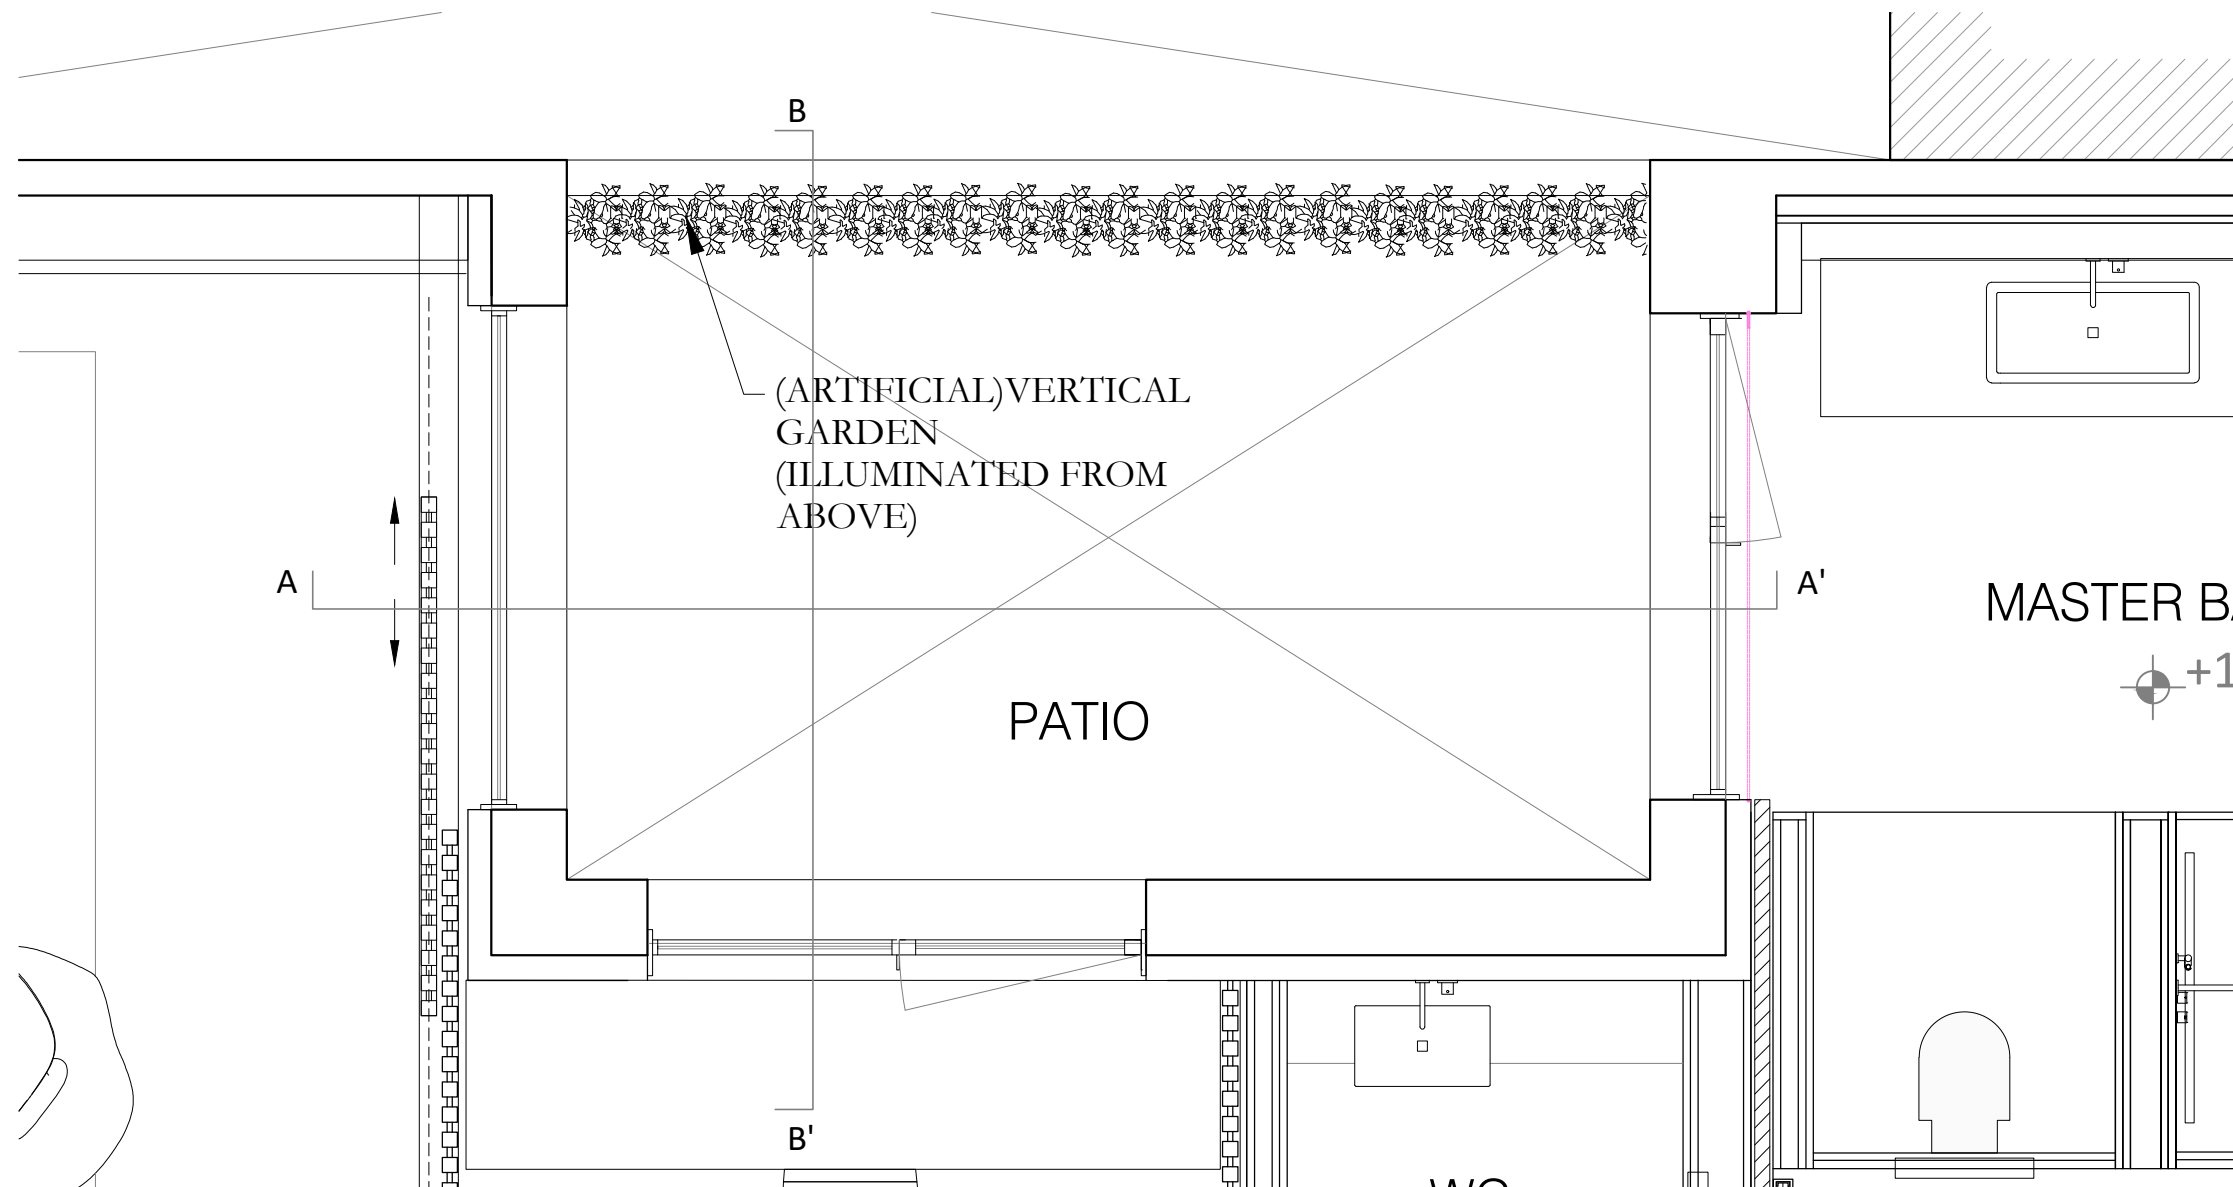


TOP VIEW VERTICAL GARDEN

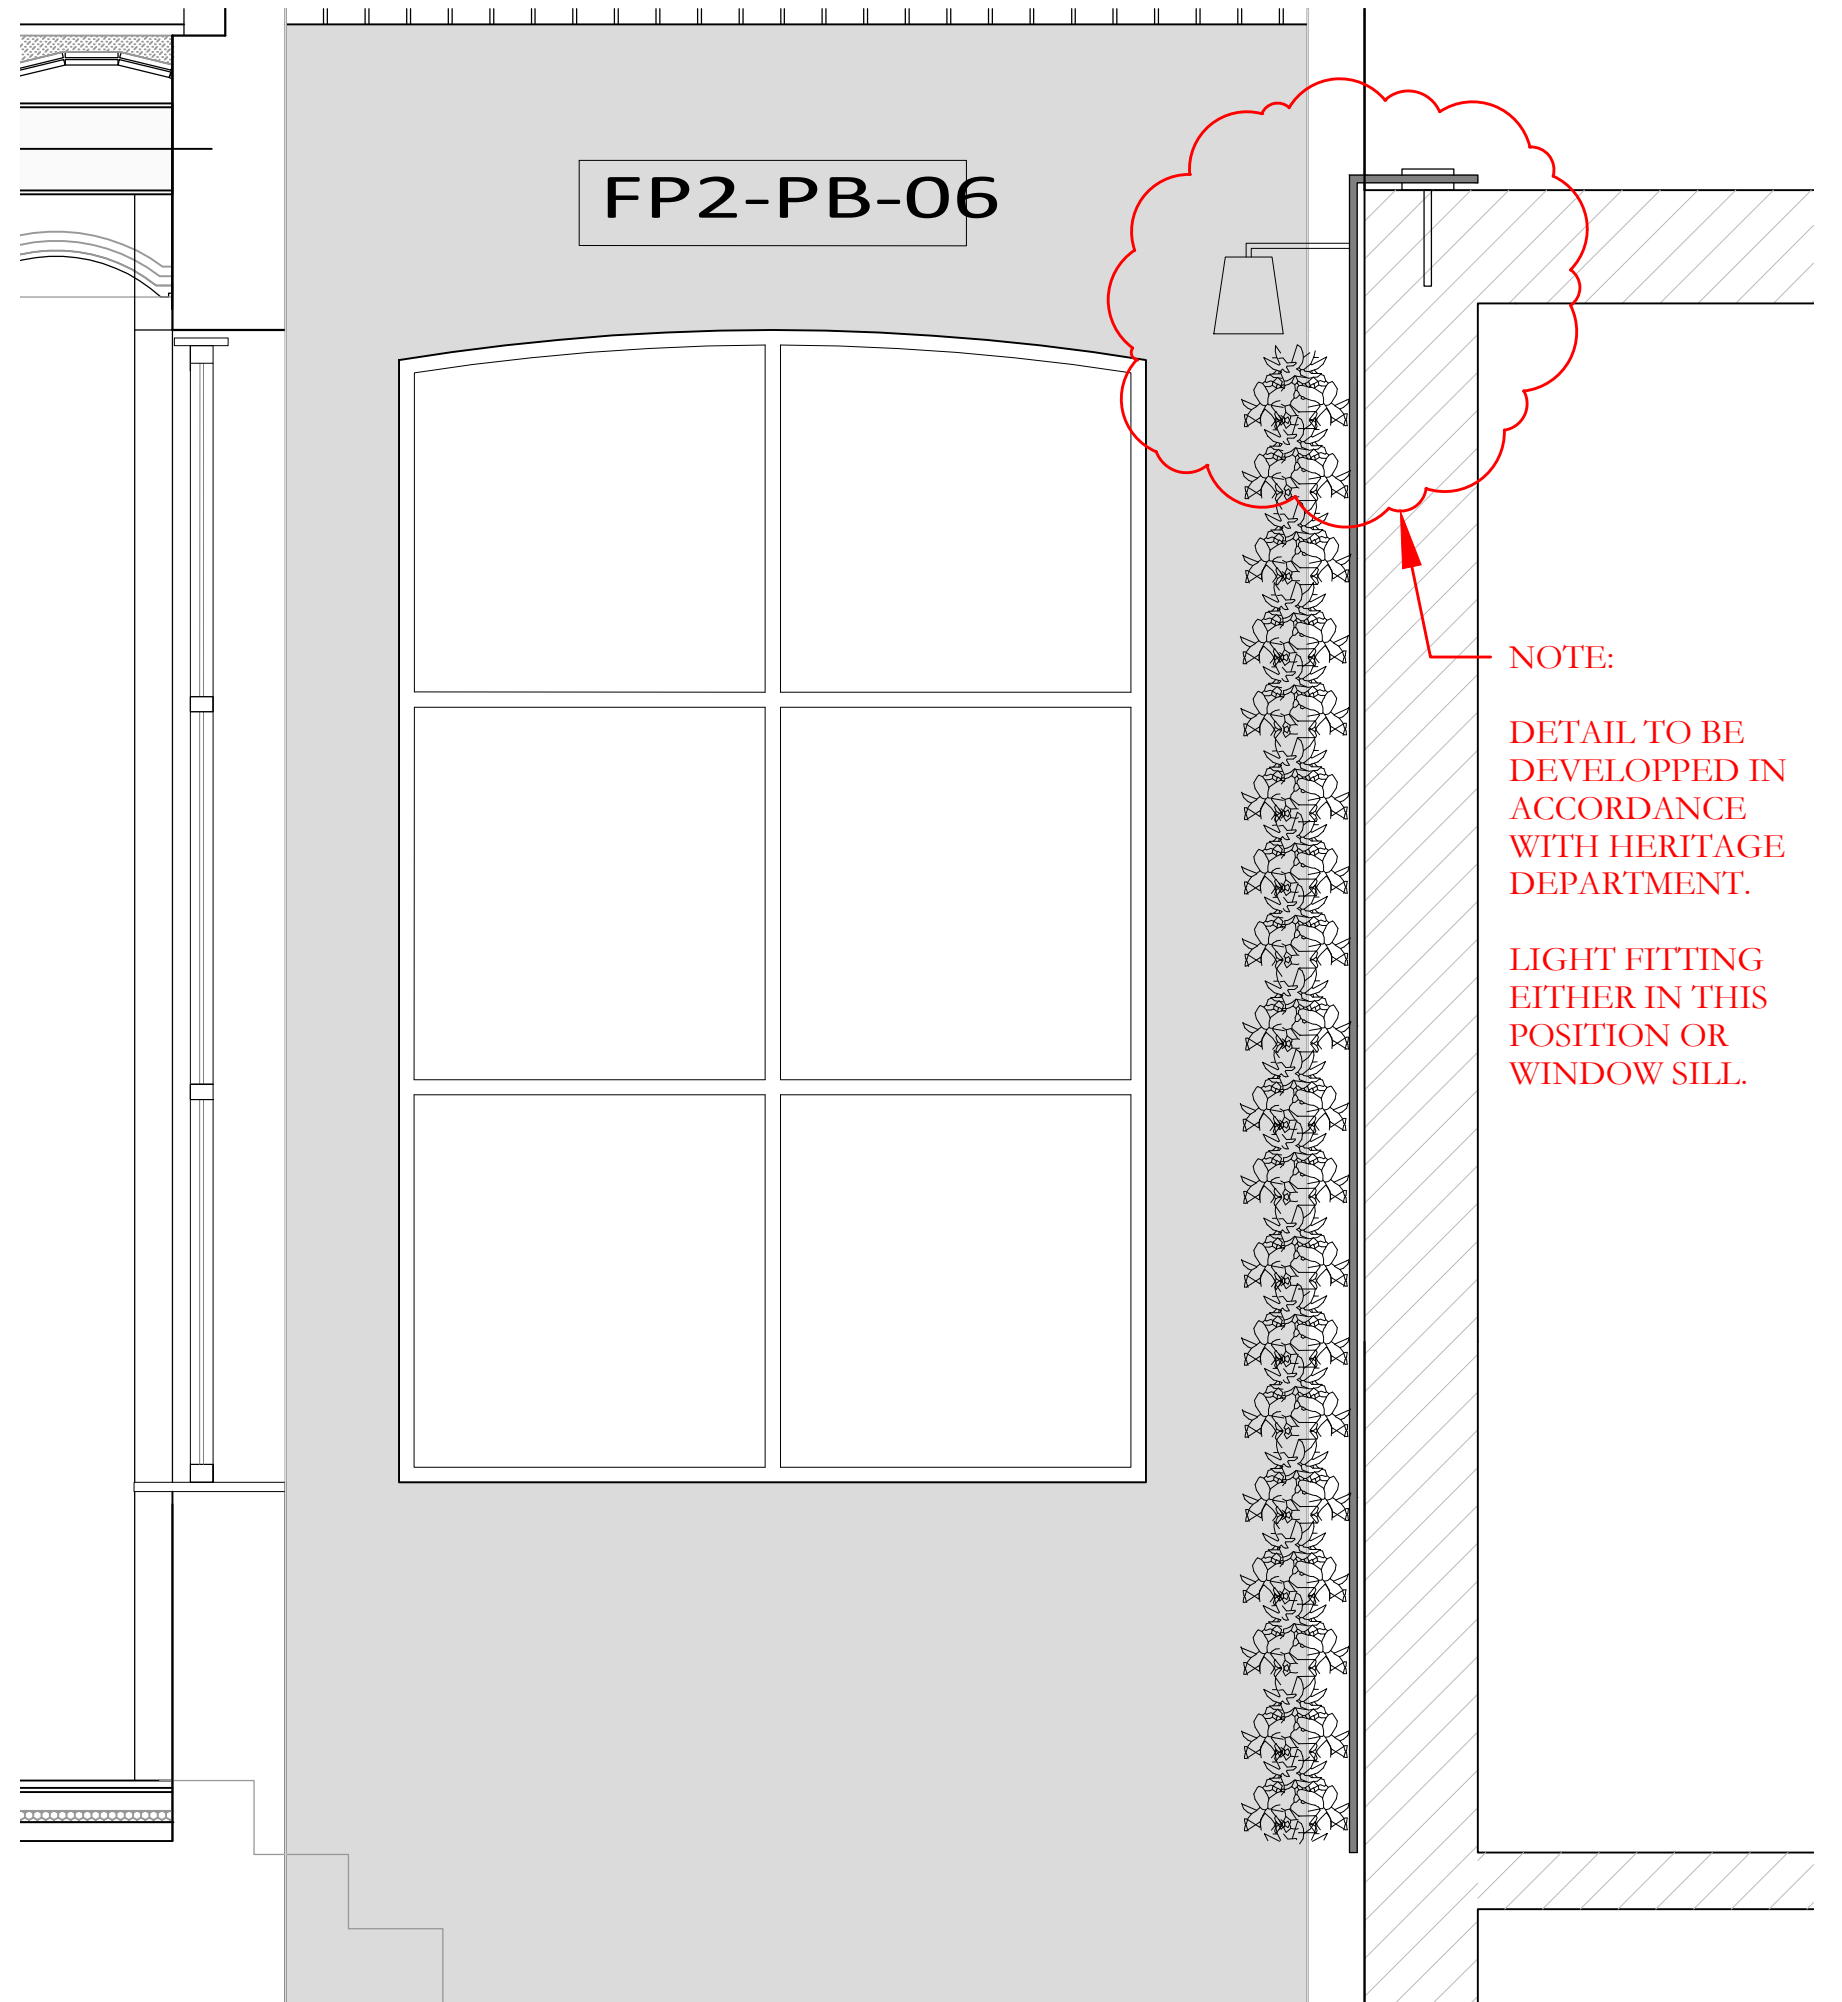

1:20 SECTION B VERTICAL GARDEN

3	-	-	-
2	JS	07.06.17	-
1	JS	30.05.17	-
0	JS	15.05.17	-
REV. Nº	NAME	DATE	NOTE
DESIGN / LAYOUT			
KIRSTEN SCHWALGIEN DESIGN KIRSTEN SCHWALGIEN DESIGN CALLE DE CAJAL 16 00100 SAN JUAN, PR WWW.KIRSTENSCHWALGIENDESIGN.COM PHONE: +1 609 531 1110 KIRSTENSCHWALGIENDESIGN.COM WWW.KIRSTENSCHWALGIENDESIGN.COM			
© Copyright. All Rights reserved to Kirsten Schwalgien Design. This drawing and the design and information it presents are the exclusive intellectual and legal property of Kirsten Schwalgien Design and may not be copied, or communicated to any third party without written consent.			
APPROVED:	DATE: 07.06.17	PROJECT Nº	
SCALE: 1:30	FORMAT: A2	CASA BURÉS LOFT 1	
DRAWN JS	DATE 07.06.17	01	SHEET 1/1
CHECK -	-	Casa Bures Sections / Details Rev 2 dated 07/06/17	
BUILDER	(DRAWN BY)		

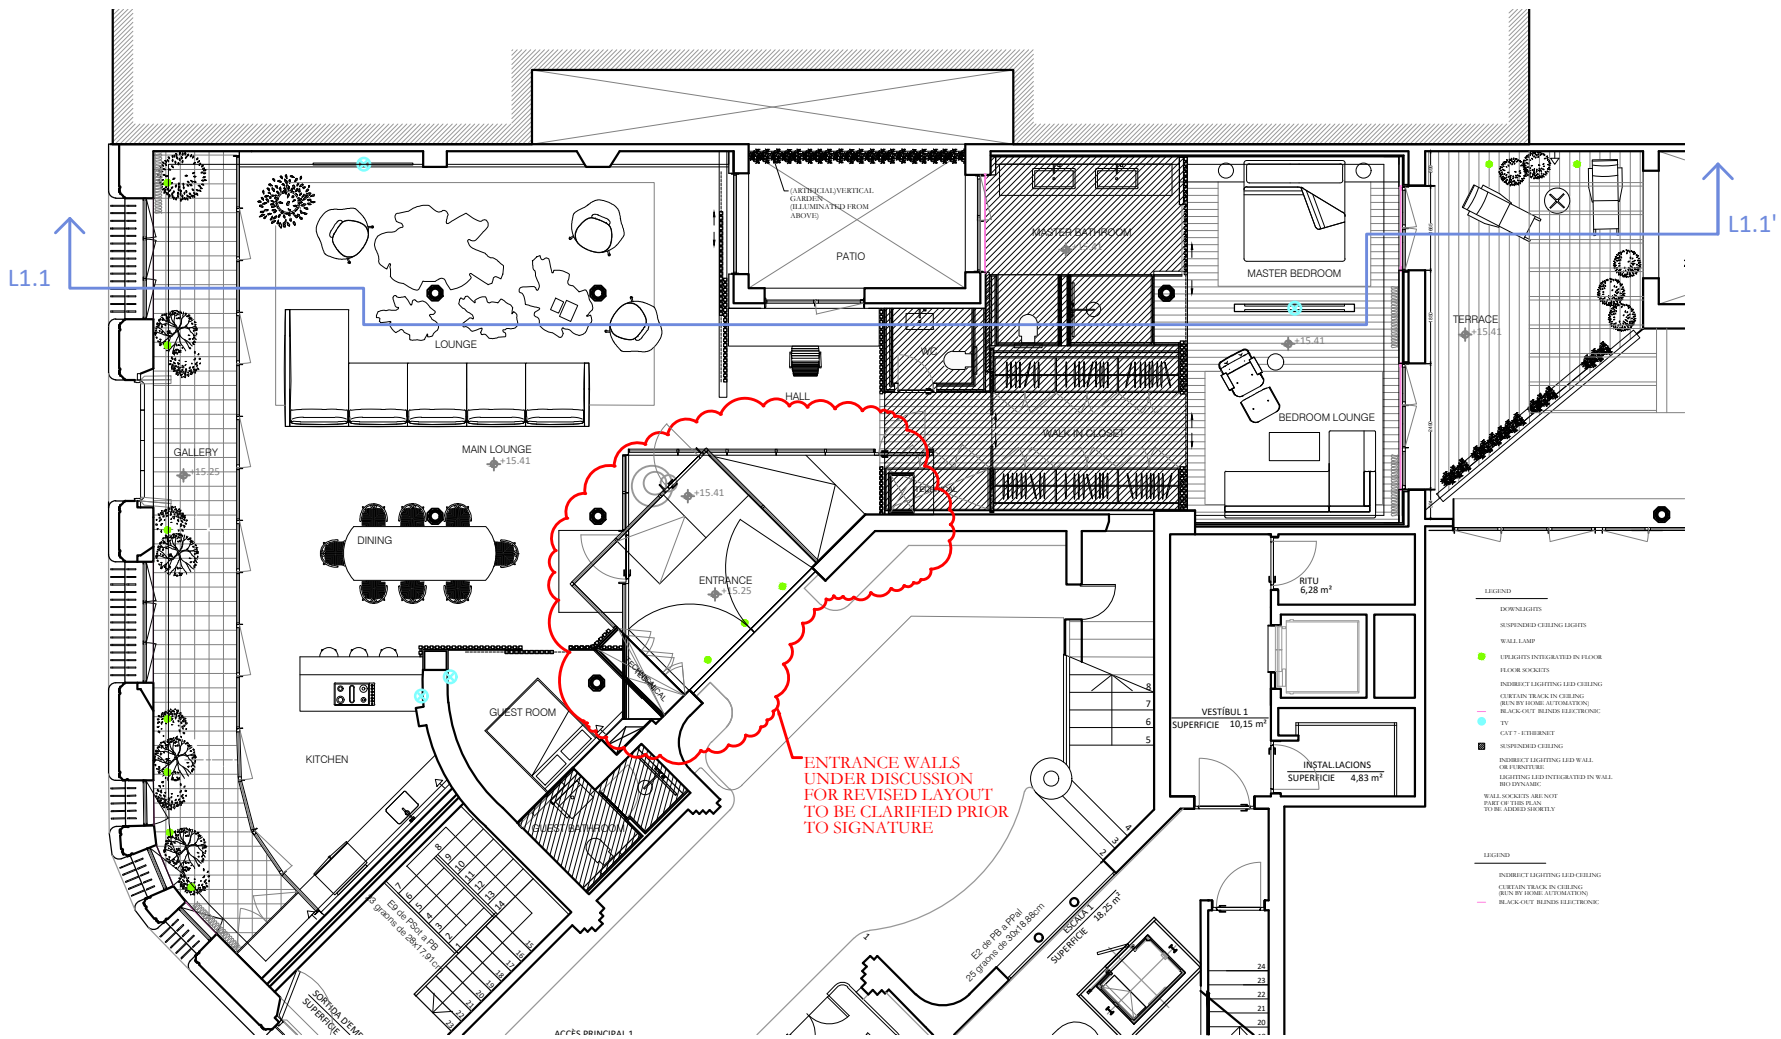


VARIATION OF
THIS DETAIL TO
BE DEVELOPPED

SUPERFÍCIES ÚTILS		
HABITATGE Baixos 1		
Tipus		
Perímetre de façana m		MC + 2H + 3CH + AP 32.41 ml
Façana mínima Sup útil/9 m		22.92 ml

Num.	espai	Descripció	Sup. útil
01	L-D-K	LOUNGE-DINING-KITCHEN	105.18 m²
02	M	MASTER BEDROOM	13.88 m²
03	B	BEDROOM LOUNGE	18.64 m²
04	W	WALK IN CLOSET	11.37 m²
05	MB	MASTER BATHROOM	12.68 m²
06	H	HALL	2.80 m²
07	WC	WC	2.48 m²
08	E	ENTRANCE	12.66 m²
09	G	GUEST ROOM	8.57 m²
10	GB	GUEST BATHROOM	4.23 m²


TOTAL SUPERFÍCIE ÚTIL			192.49m²
-----------------------	--	--	----------

SUPERFÍCIES ÚTILS EXTERIORS			
espai	Num.	Descripció	Superfície
Cobert	EI01	PORXO	23.17 m²
Cobert	EI02	GALERIA	26.57 m²

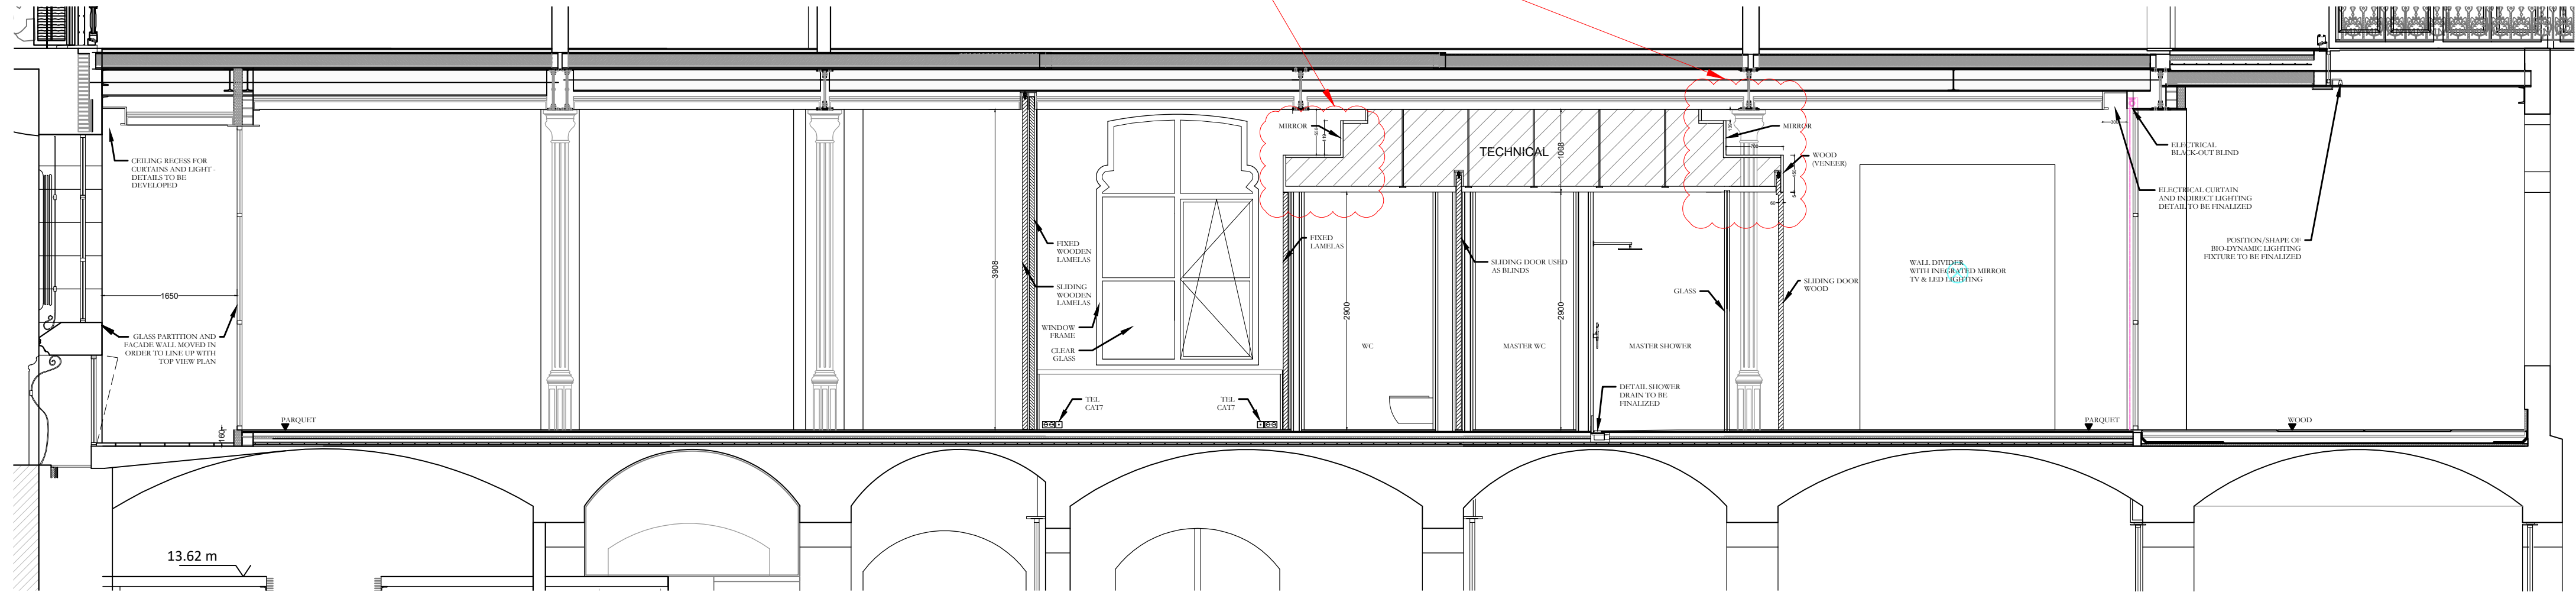

SECTION L1.1

3				
2	JS	08.06.17	-	
1	JS	30.05.17	-	
0	JS	15.05.17	-	
REV. Nº	NAME	DATE	NOTE	
DESIGN / LAYOUT				
 KIRSTEN SCHWALGIEN DESIGN				
KIRSTEN SCHWALGIEN DESIGN C/IBER DE GRIP 16 08005 BARCELONA TEL: +34 608 83 11 70 EMAIL: KIRSTEN@SCHWALGIEN.COM WWW.SCHWALGIEN.COM				
© Copyright: All Rights reserved by Kirsten Schwalgien Design.				
APPROVED -	DATE: 08.06.17	PROJECT Nº	CASA BURÉS LOFT 1	
SCALE NO SCALE	FORMAT: A2	CRDRAWING Nº	01	
DRAWN JS	DATE: 08.06.17		1/3	
CHECK -				
BUILDER			Casa Bures Sections / Details	
			Rev 2 dated 08/06/17	

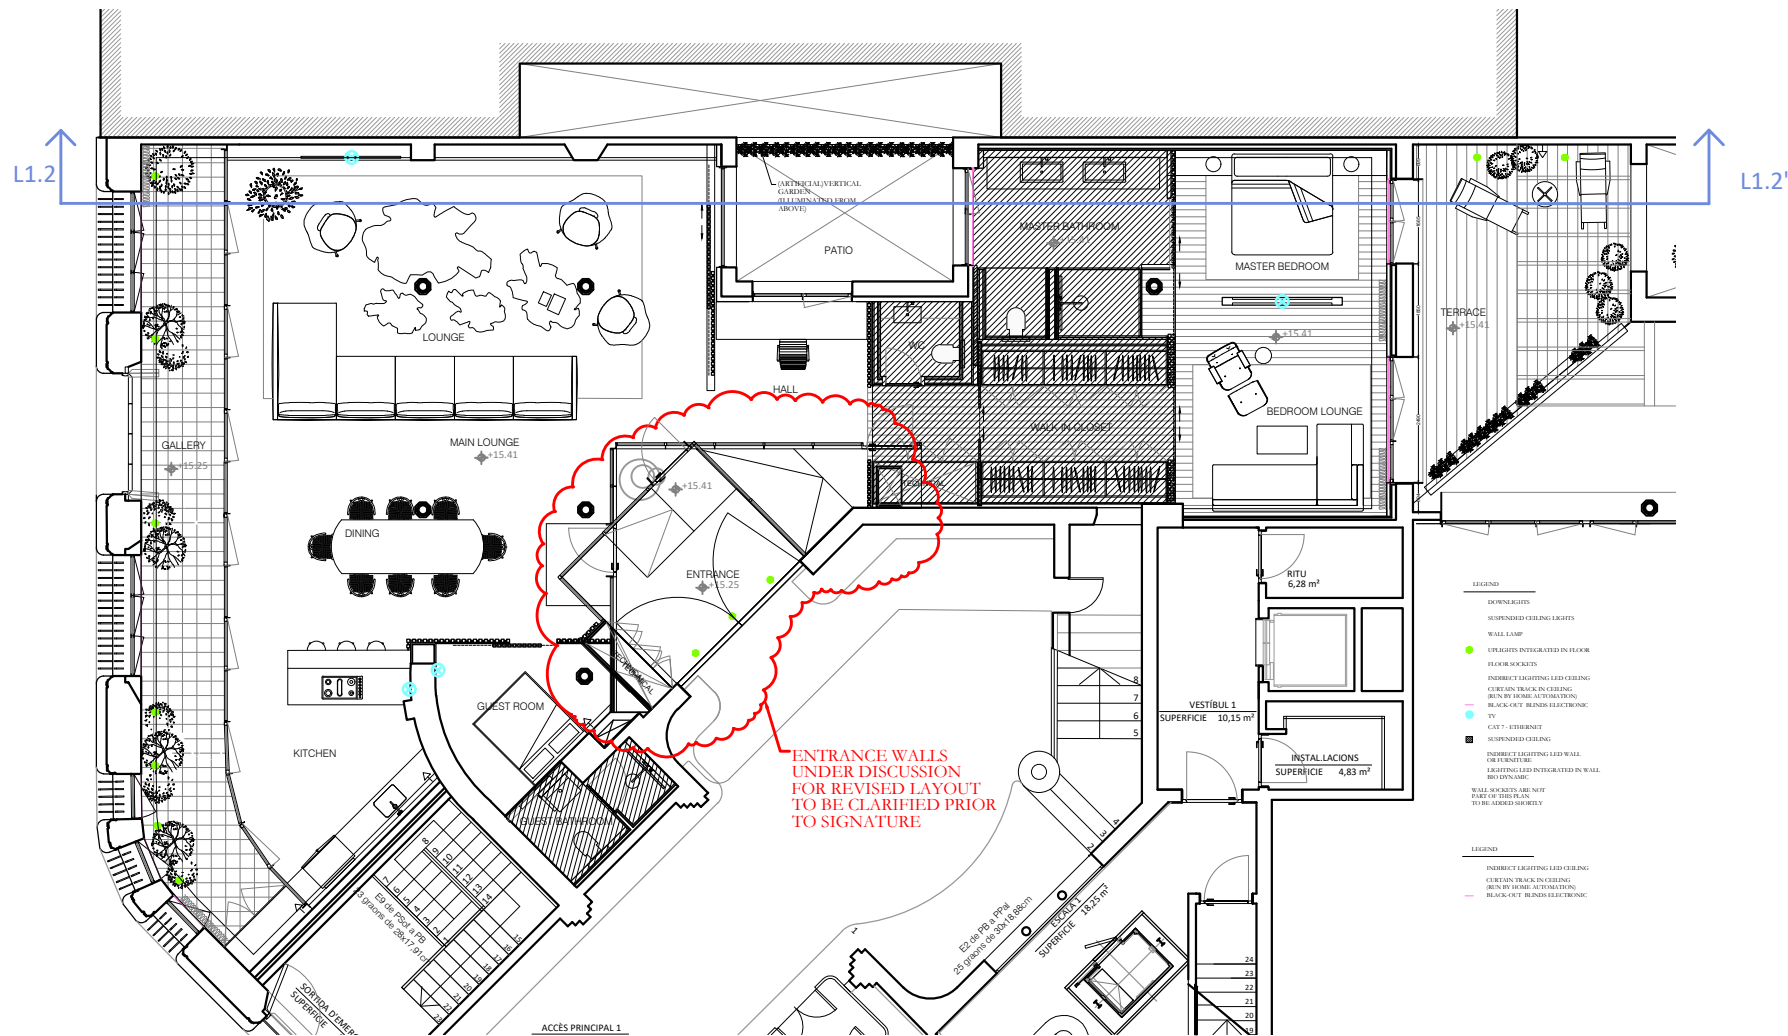

SUPERFÍCIES ÚTILS
HABITATGE Baixos 1

Tipus MC + 2H + 3CH + AP
Perímetre de façana m 32.41 ml
Façana mínima Sup útil/9 m 22.92 ml

Num.	espai	Descripció	Sup. útil
01	L-D-K	LOUNGE-DINING-KITCHEN	105.18 m²
02	M	MASTER BEDROOM	13.88 m²
03	B	BEDROOM LOUNGE	18.64 m²
04	W	WALK IN CLOSET	11.37 m²
05	MB	MASTER BATHROOM	12.68 m²
06	H	HALL	2.80 m²
07	WC	WC	2.48 m²
08	E	ENTRANCE	12.66 m²
09	G	GUEST ROOM	8.57 m²
10	GB	GUEST BATHROOM	4.23 m²

TOTAL SUPERFÍCIE ÚTIL 192.49m²

SUPERFÍCIES ÚTILS EXTERIORS

espai	Num.	Descripció	Superficie
Cobert	EI01	PORXO	23.17 m²
Cobert	EI02	GALERIA	26.57 m²



SECTION LOFT 1.2

3				
2	JS	07.06.17	-	
1	JS	30.05.17	-	
0	JS	15.05.17	-	
REV. Nº	NAME	DATE	NOTE	
DESIGN / LAYOUT				
 KIRSTEN SCHWALGIEN DESIGN				
KIRSTEN SCHWALGIEN DESIGN C/IBER DE CADE 16 08005 BARCELONA +34 608 83 11 70 kirstenschwalgien.com www.kirstenschwalgien.com				
© Copyright: All Rights reserved by Kirsten Schwalgien Design.				
APPROVED: -		DATE: 07.06.17	PROJECT Nº	
SCALE NO SCALE	FORMAT: A2	CASA BURÉS LOFT 1		
DRAWN JS	DATE: 07.06.17	DRAWING Nº		
CHECK -	-	01		
BUILDER	-	SHEET 1/1		
Casa Bures Sections / Details Rev 2 dated 07/06/17				